



1. DO NOT SCALE DRAWING
 2. DIMENSIONS TO BE USED UNLESS OTHERWISE STATED.
 3. TOLERANCES DIM FRACTIONAL DIMENSIONS UNLESS OTHERWISE STATED.
 4. IF IN DOUBT ABOUT THIS DRAWING, RING DRAWING OFFICE, BEIDIE, COMMENCING OPERATIONS.

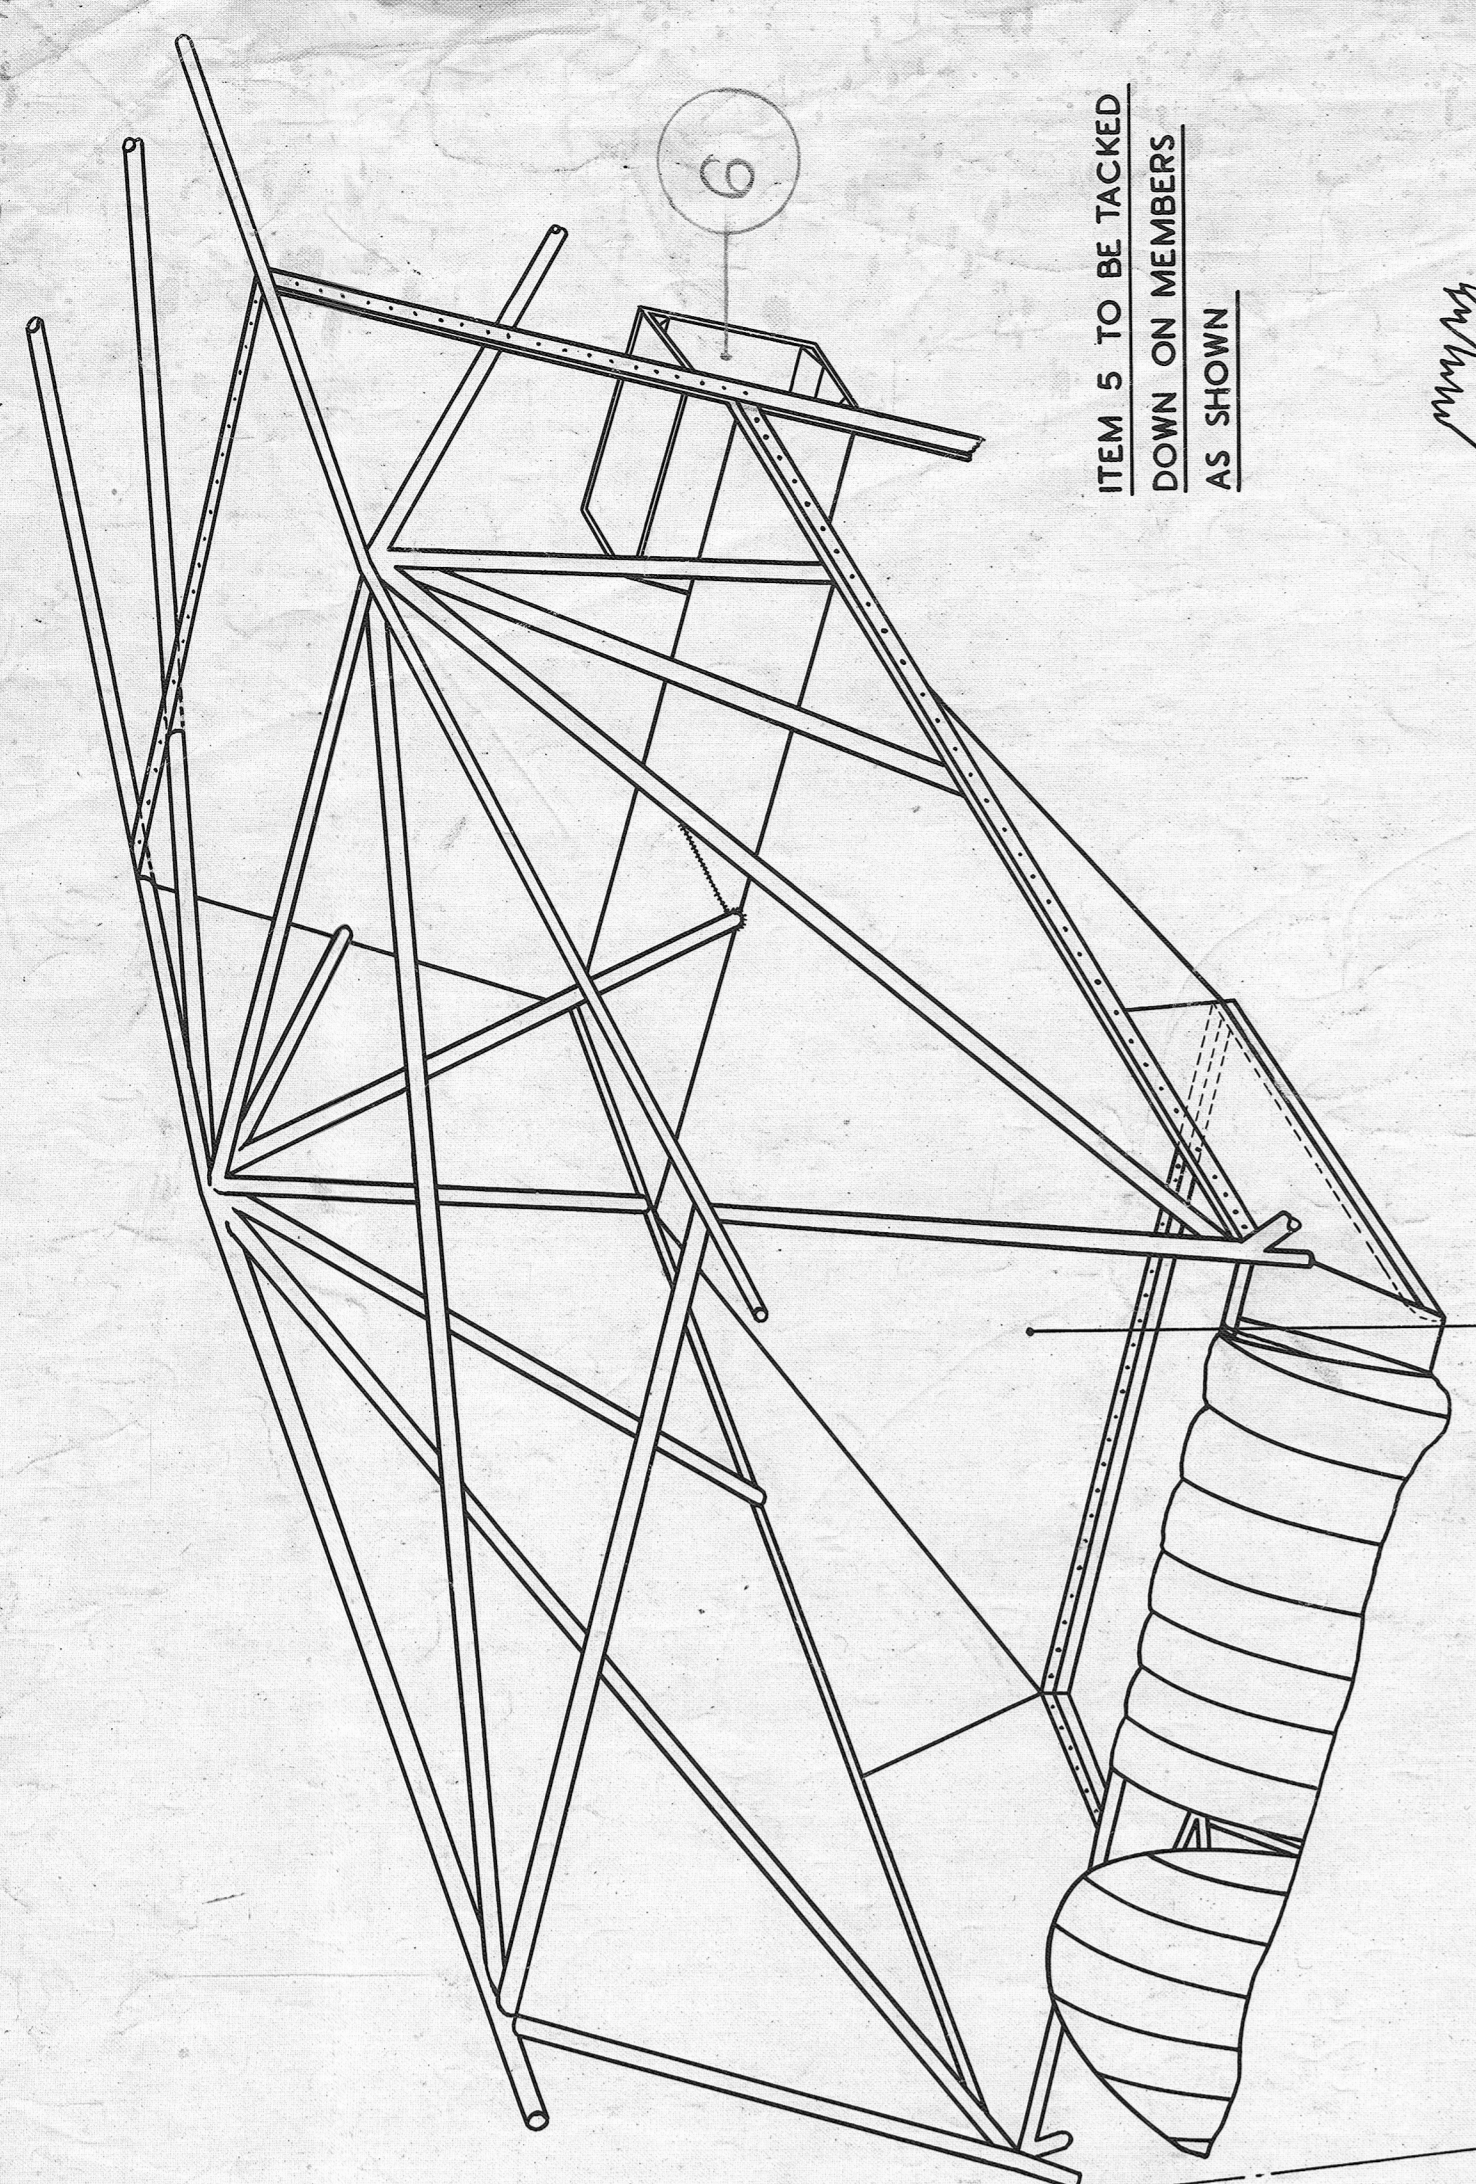

ITEM 5 TO BE TACKED
 DOWN ON MEMBERS
 AS SHOWN

VIEW SHOWING HOW
 ITEM 5 IS TACKED
 ONTO WINDOW FRAME

THREE QUARTER TOP VIEW
 INTO CABIN SHOWING
 ATTACHMENT OF ITEM 5

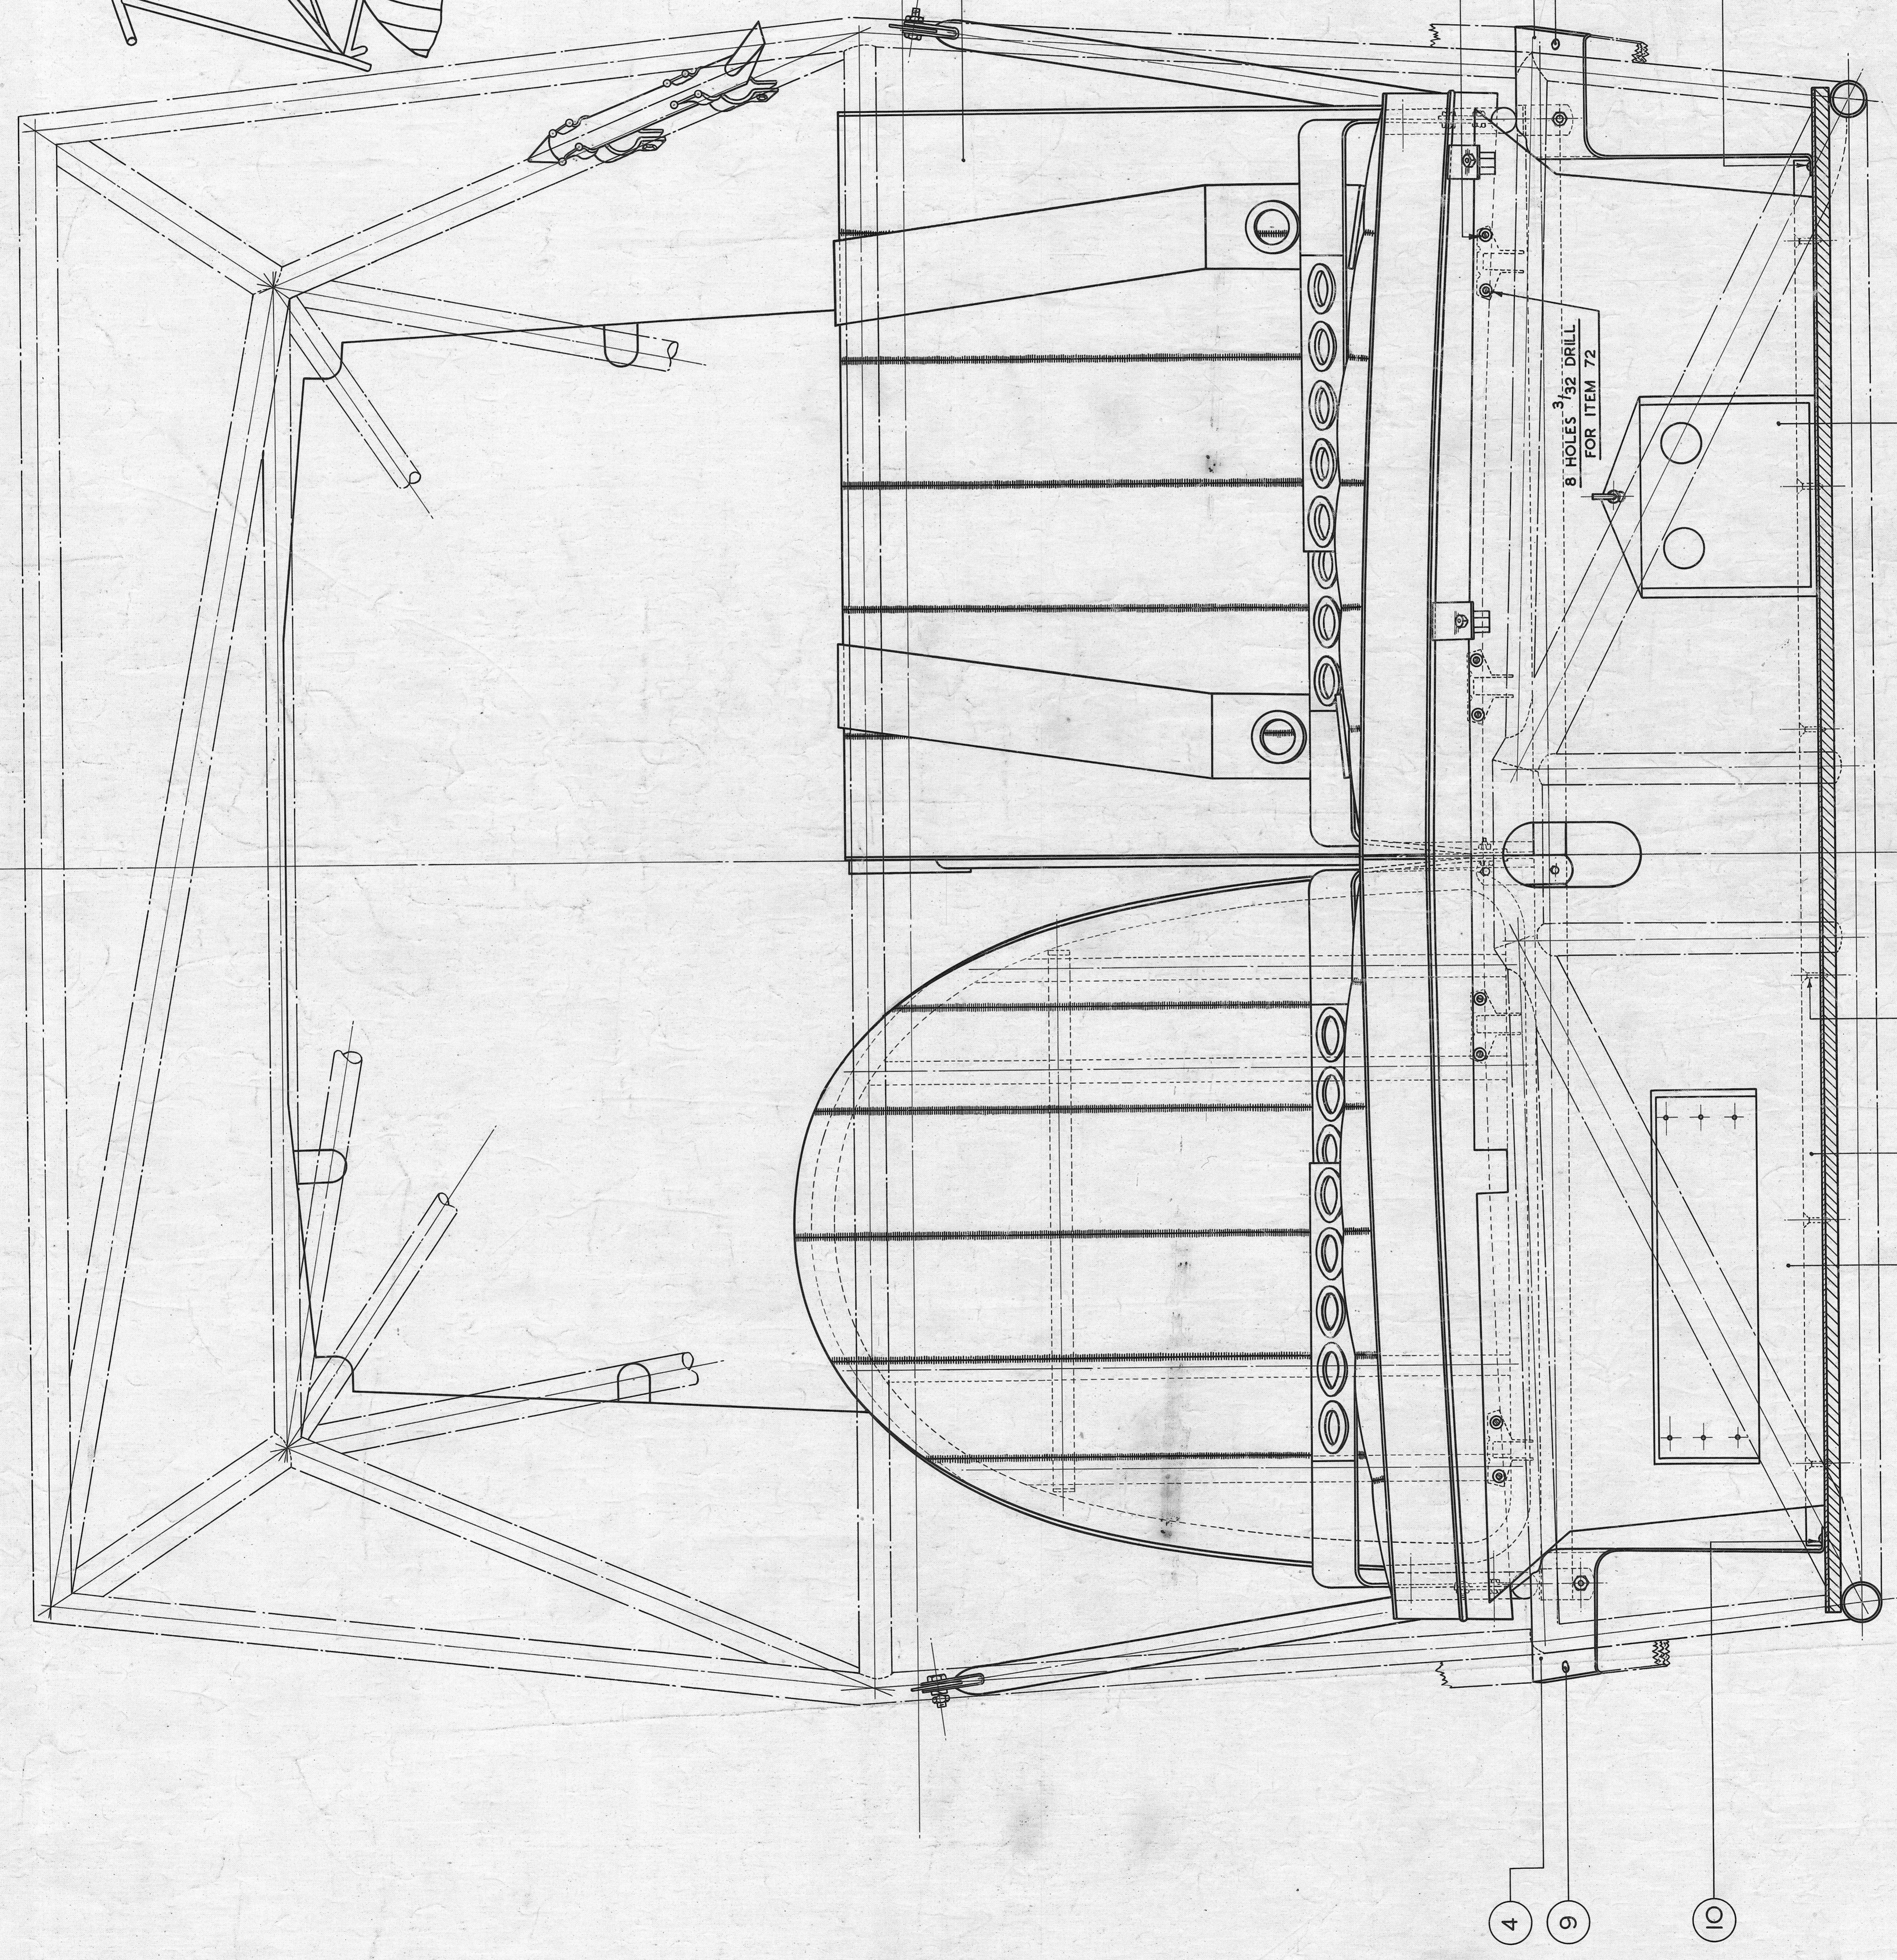

8 HOLES $\frac{3}{16}$ DRILL
 FOR ITEM 72

PROTECTIVE TREATMENT	Asst. View EE 3
SCALE	1 - 2
DRAWN BY	R.C. TAYLOR
CHECKED BY	R.C. TAYLOR
DESIGNER	R.C. TAYLOR
APPROVED BY	R.C. TAYLOR
TITLE	ASSEMBLY OF CABIN FITTINGS (VIEW AFT)

NOTE THIS DRC IS FOR AUSTER MK II MACHINES ONLY
 FOR FORWARD VIEW AUSTER MK II SEE SHEET No 1
 FOR SIDE VIEW AUSTER MK II SEE SHEET No 2
 FOR PLAN VIEW AUSTER MK II SEE SHEET No 3

No	Type	Description	Quantity	AS REQD
14	No 6	CUP WASHER	8	8
13	Type Z	PARKER KALON SCREW	8	8
12		CEMENT COATED NAIL	8	6
11	ACS	WOODSCREW	6	6
10	250/21	WOODSCREW	6	6
9	ACS	WOODSCREW	8	8
8	B 777	REAR FLOORBD STIFFAR	ADC 110	1
7	BA 753	DEVIATION CARD HOLDER	DEC 15	1
6	70018	FIRST AID BOX ASSY.	DEC 15	1
5		BACK CLOTH	GREEN BAIZE	AS REQD
4	70018	CABIN CABLE COVER (STBD)	DDC 402	1
3	BA 753	CABIN CABLE COVER (P.T)	DDC 8 MK	1
2	70008	KICKING BOARD	CEC 14	1
1	70001	C.A. OF SEATING	EFC 3	1

20	180	117/9	3	
19	180	114/6	3	
18	180	1047	3	
17	180	91	3	
Issue	Not	Class	App	RTO
Issue	Not	Class	App	RTO

TYPE: AUSTER